



**Transfer Station Offices**  
 Middletown Avenue Landfill  
 New Haven, Connecticut  
 Reflected Ceiling Plan

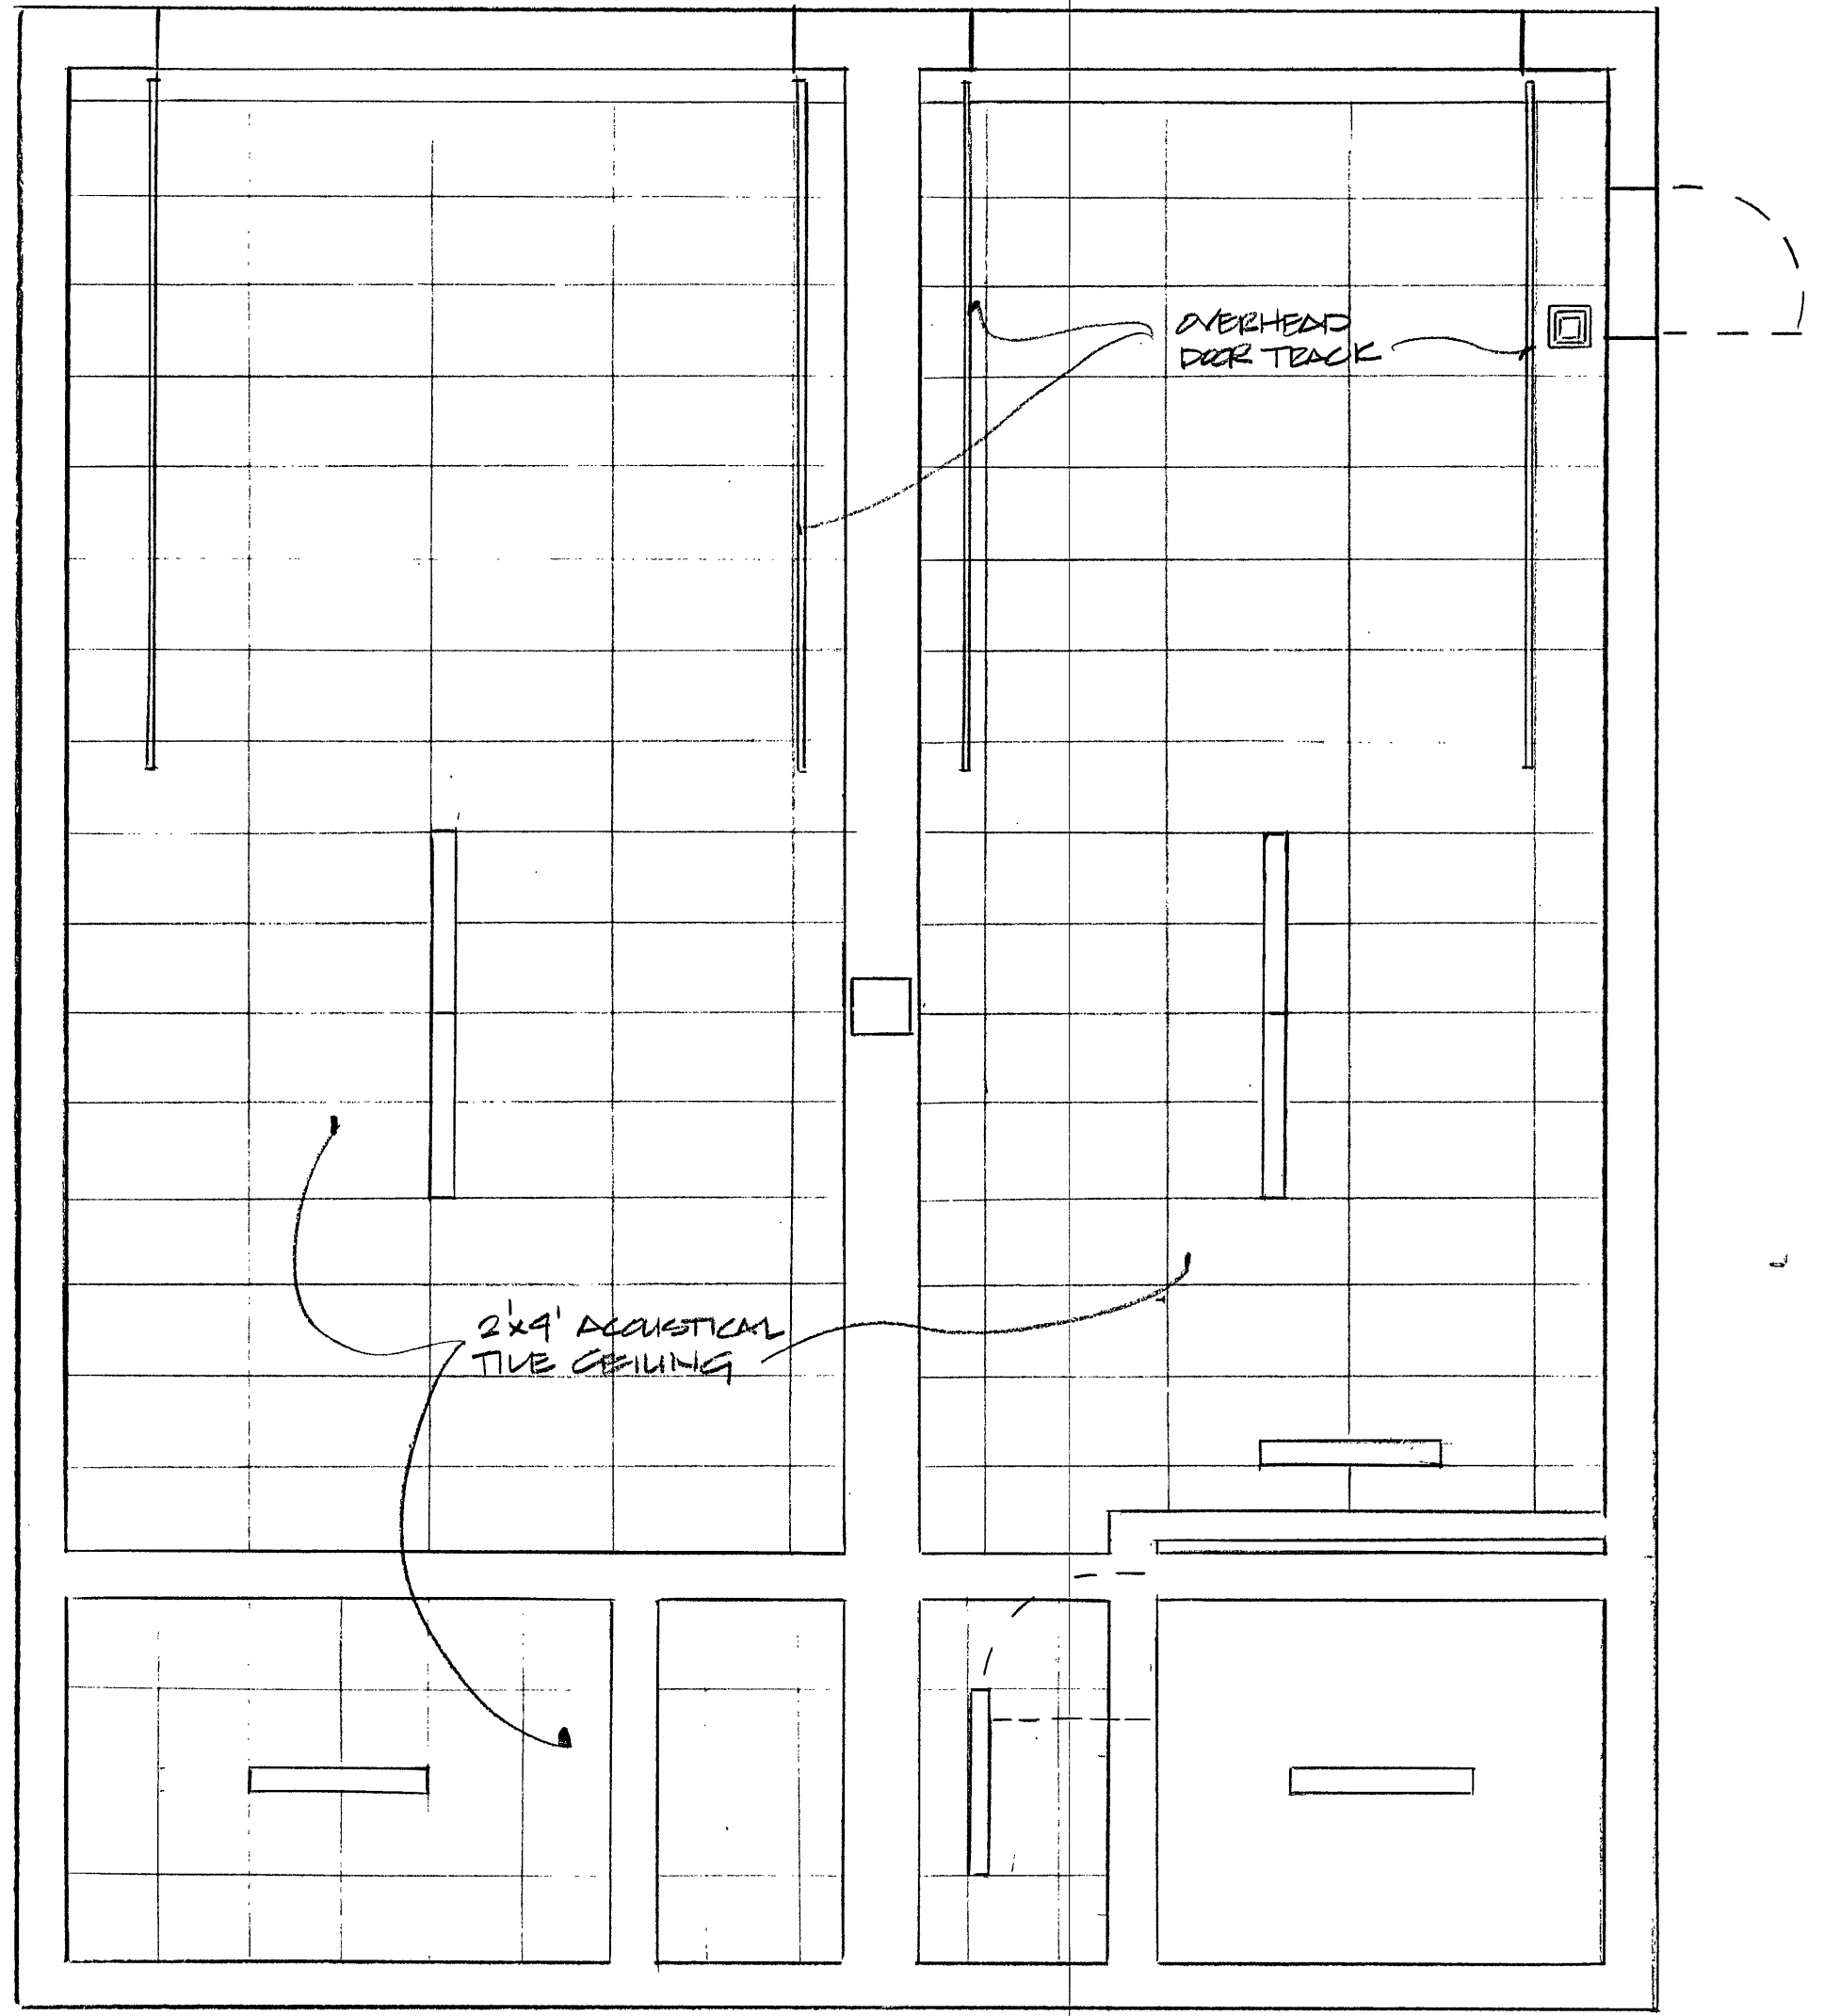

1 LOWER LEVEL REFLECTED CEILING PLAN  
 N13 SCALE: 1/4" = 1'-0"

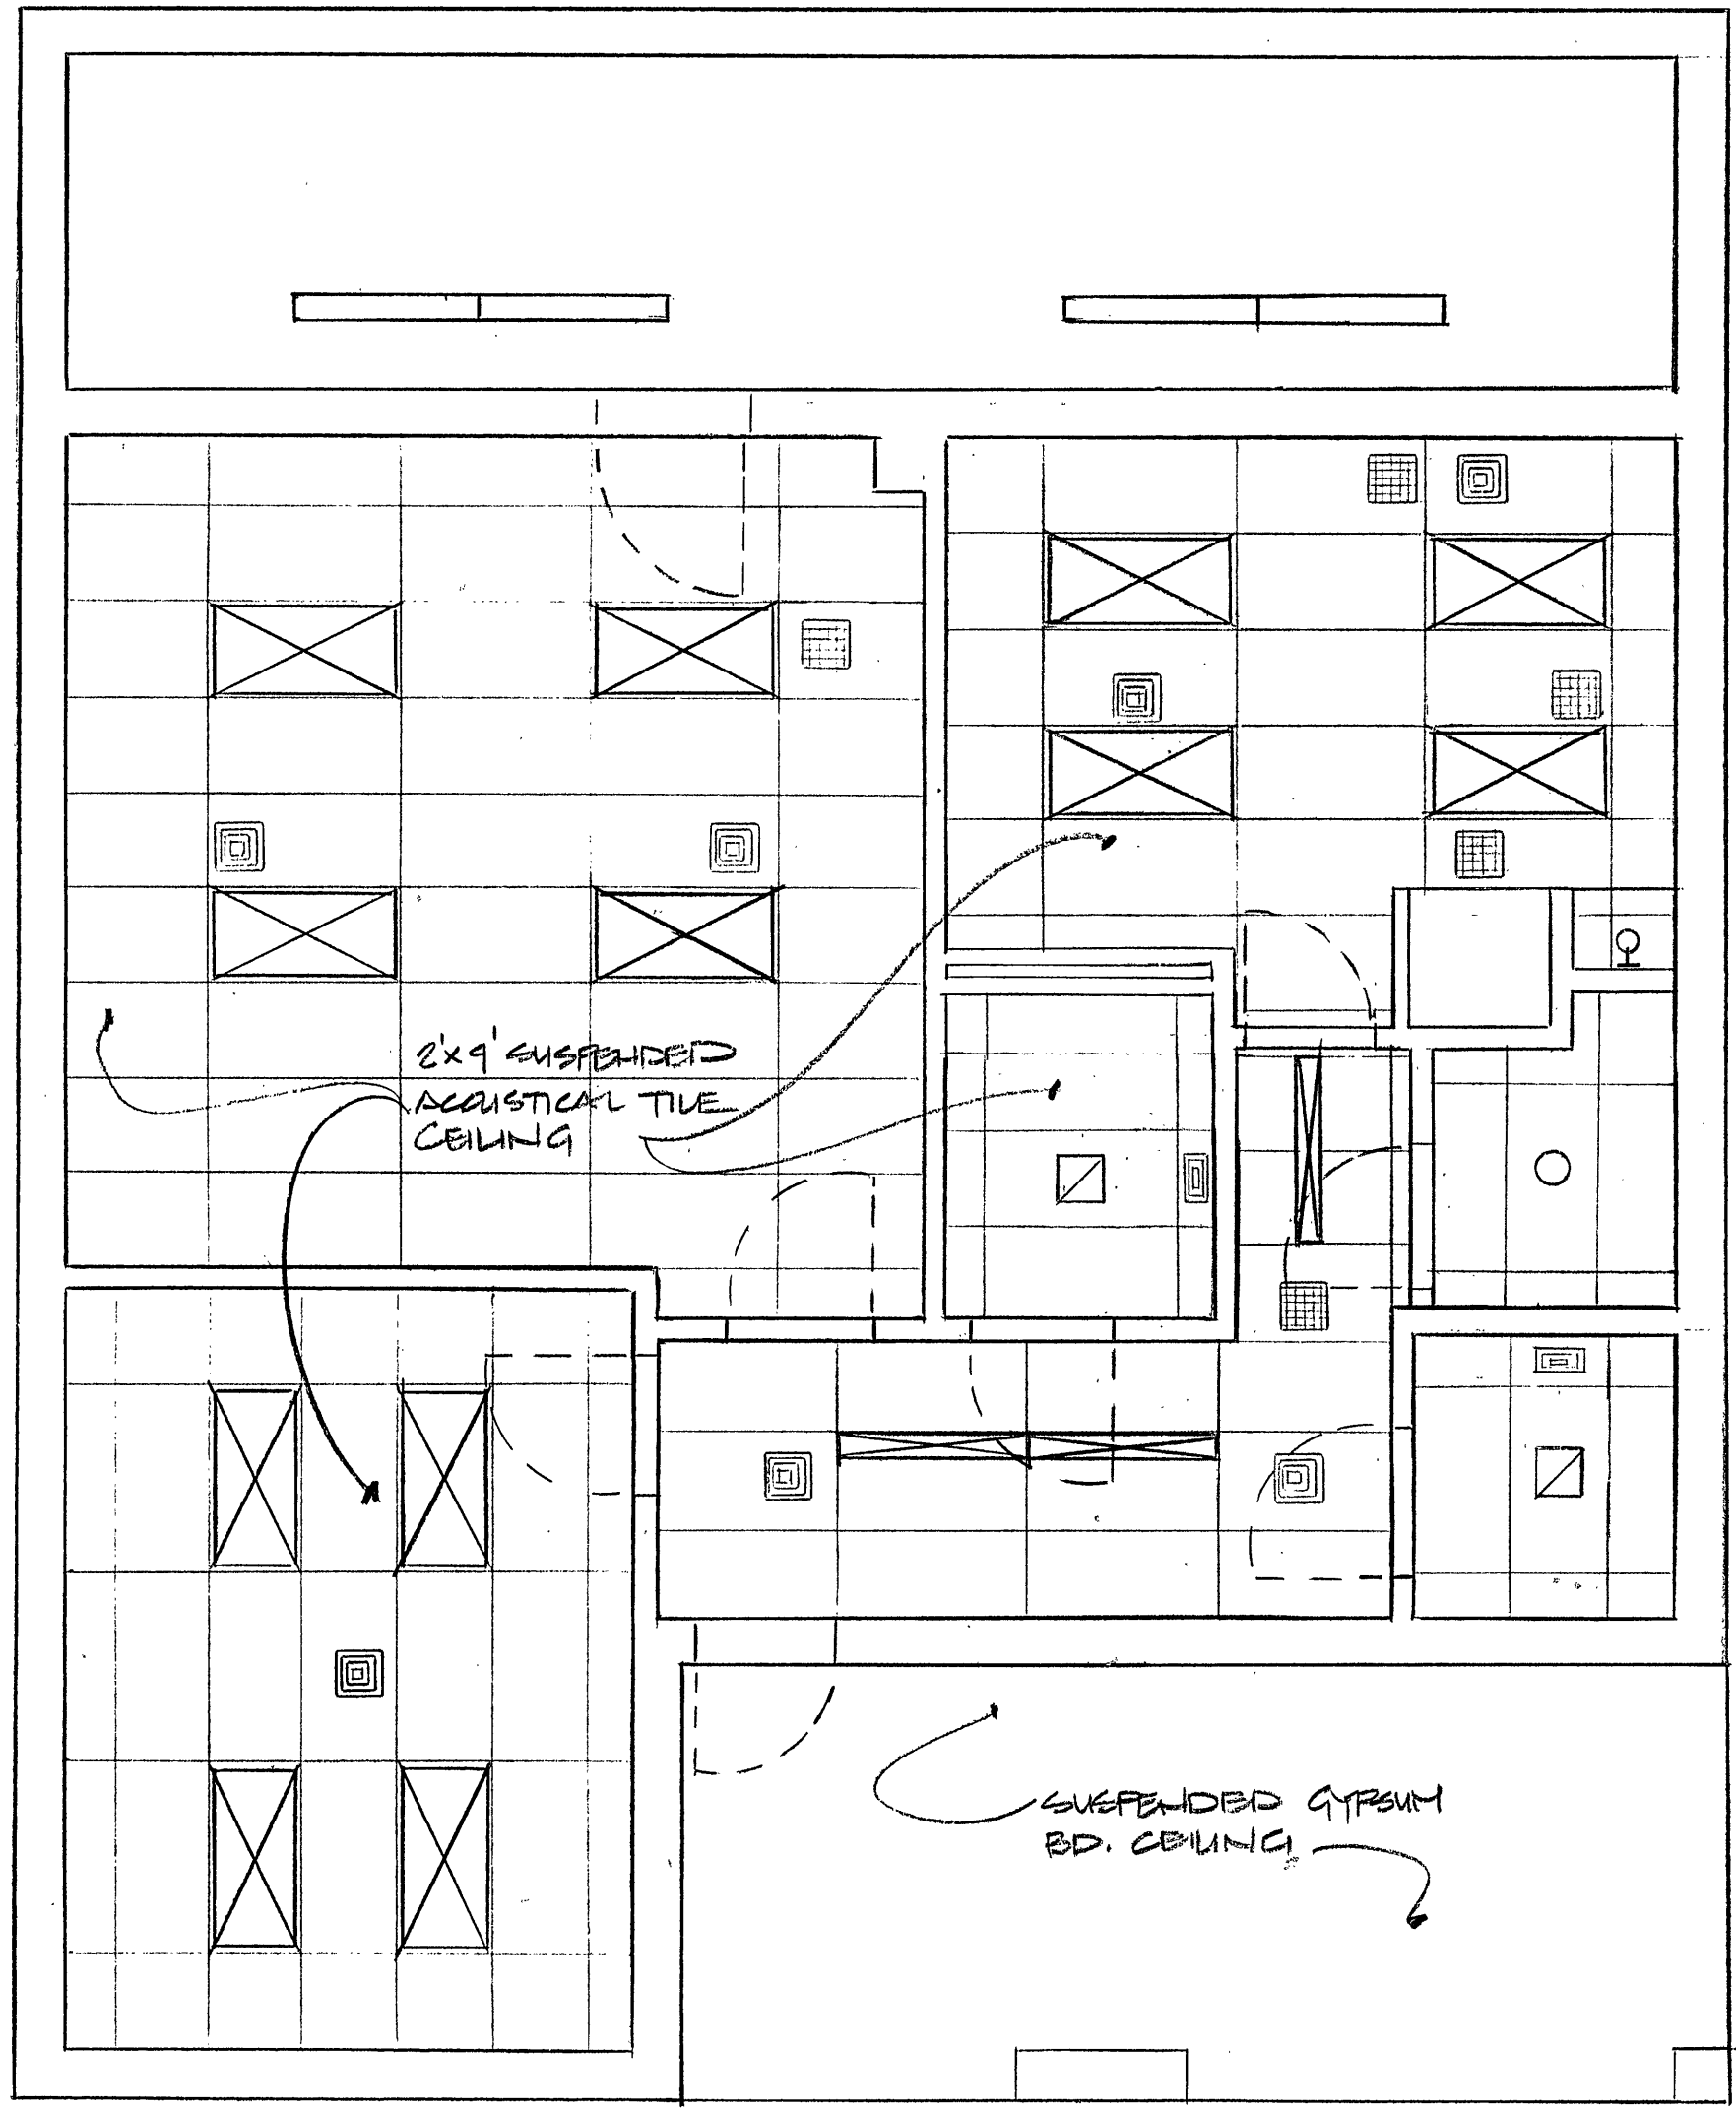

2 UPPER LEVEL REFLECTED CEILING PLAN  
 N10 SCALE: 1/4" = 1'-0"

- LEGEND**
- SUPPLY AIR DIFFUSER
  - RETURN AIR GRILL
  - WALL MOUNT LIGHT FIXTURE
  - FAN/LIGHT RECESSED
  - SURFACE MOUNT LIGHT FIXTURES
  - RECESSED LIGHT FIXTURES

Drawn by: SKB Checked by: SKB  
 Date: JULY 2, 1990  
 Revisions: