


Transfer Station

Middletown Avenue Landfill
New Haven, Connecticut

Lower Level Electrical Plan

Drawn by: SKB Checked by: CKS
Date: JULY 2, 1990
Revisions:

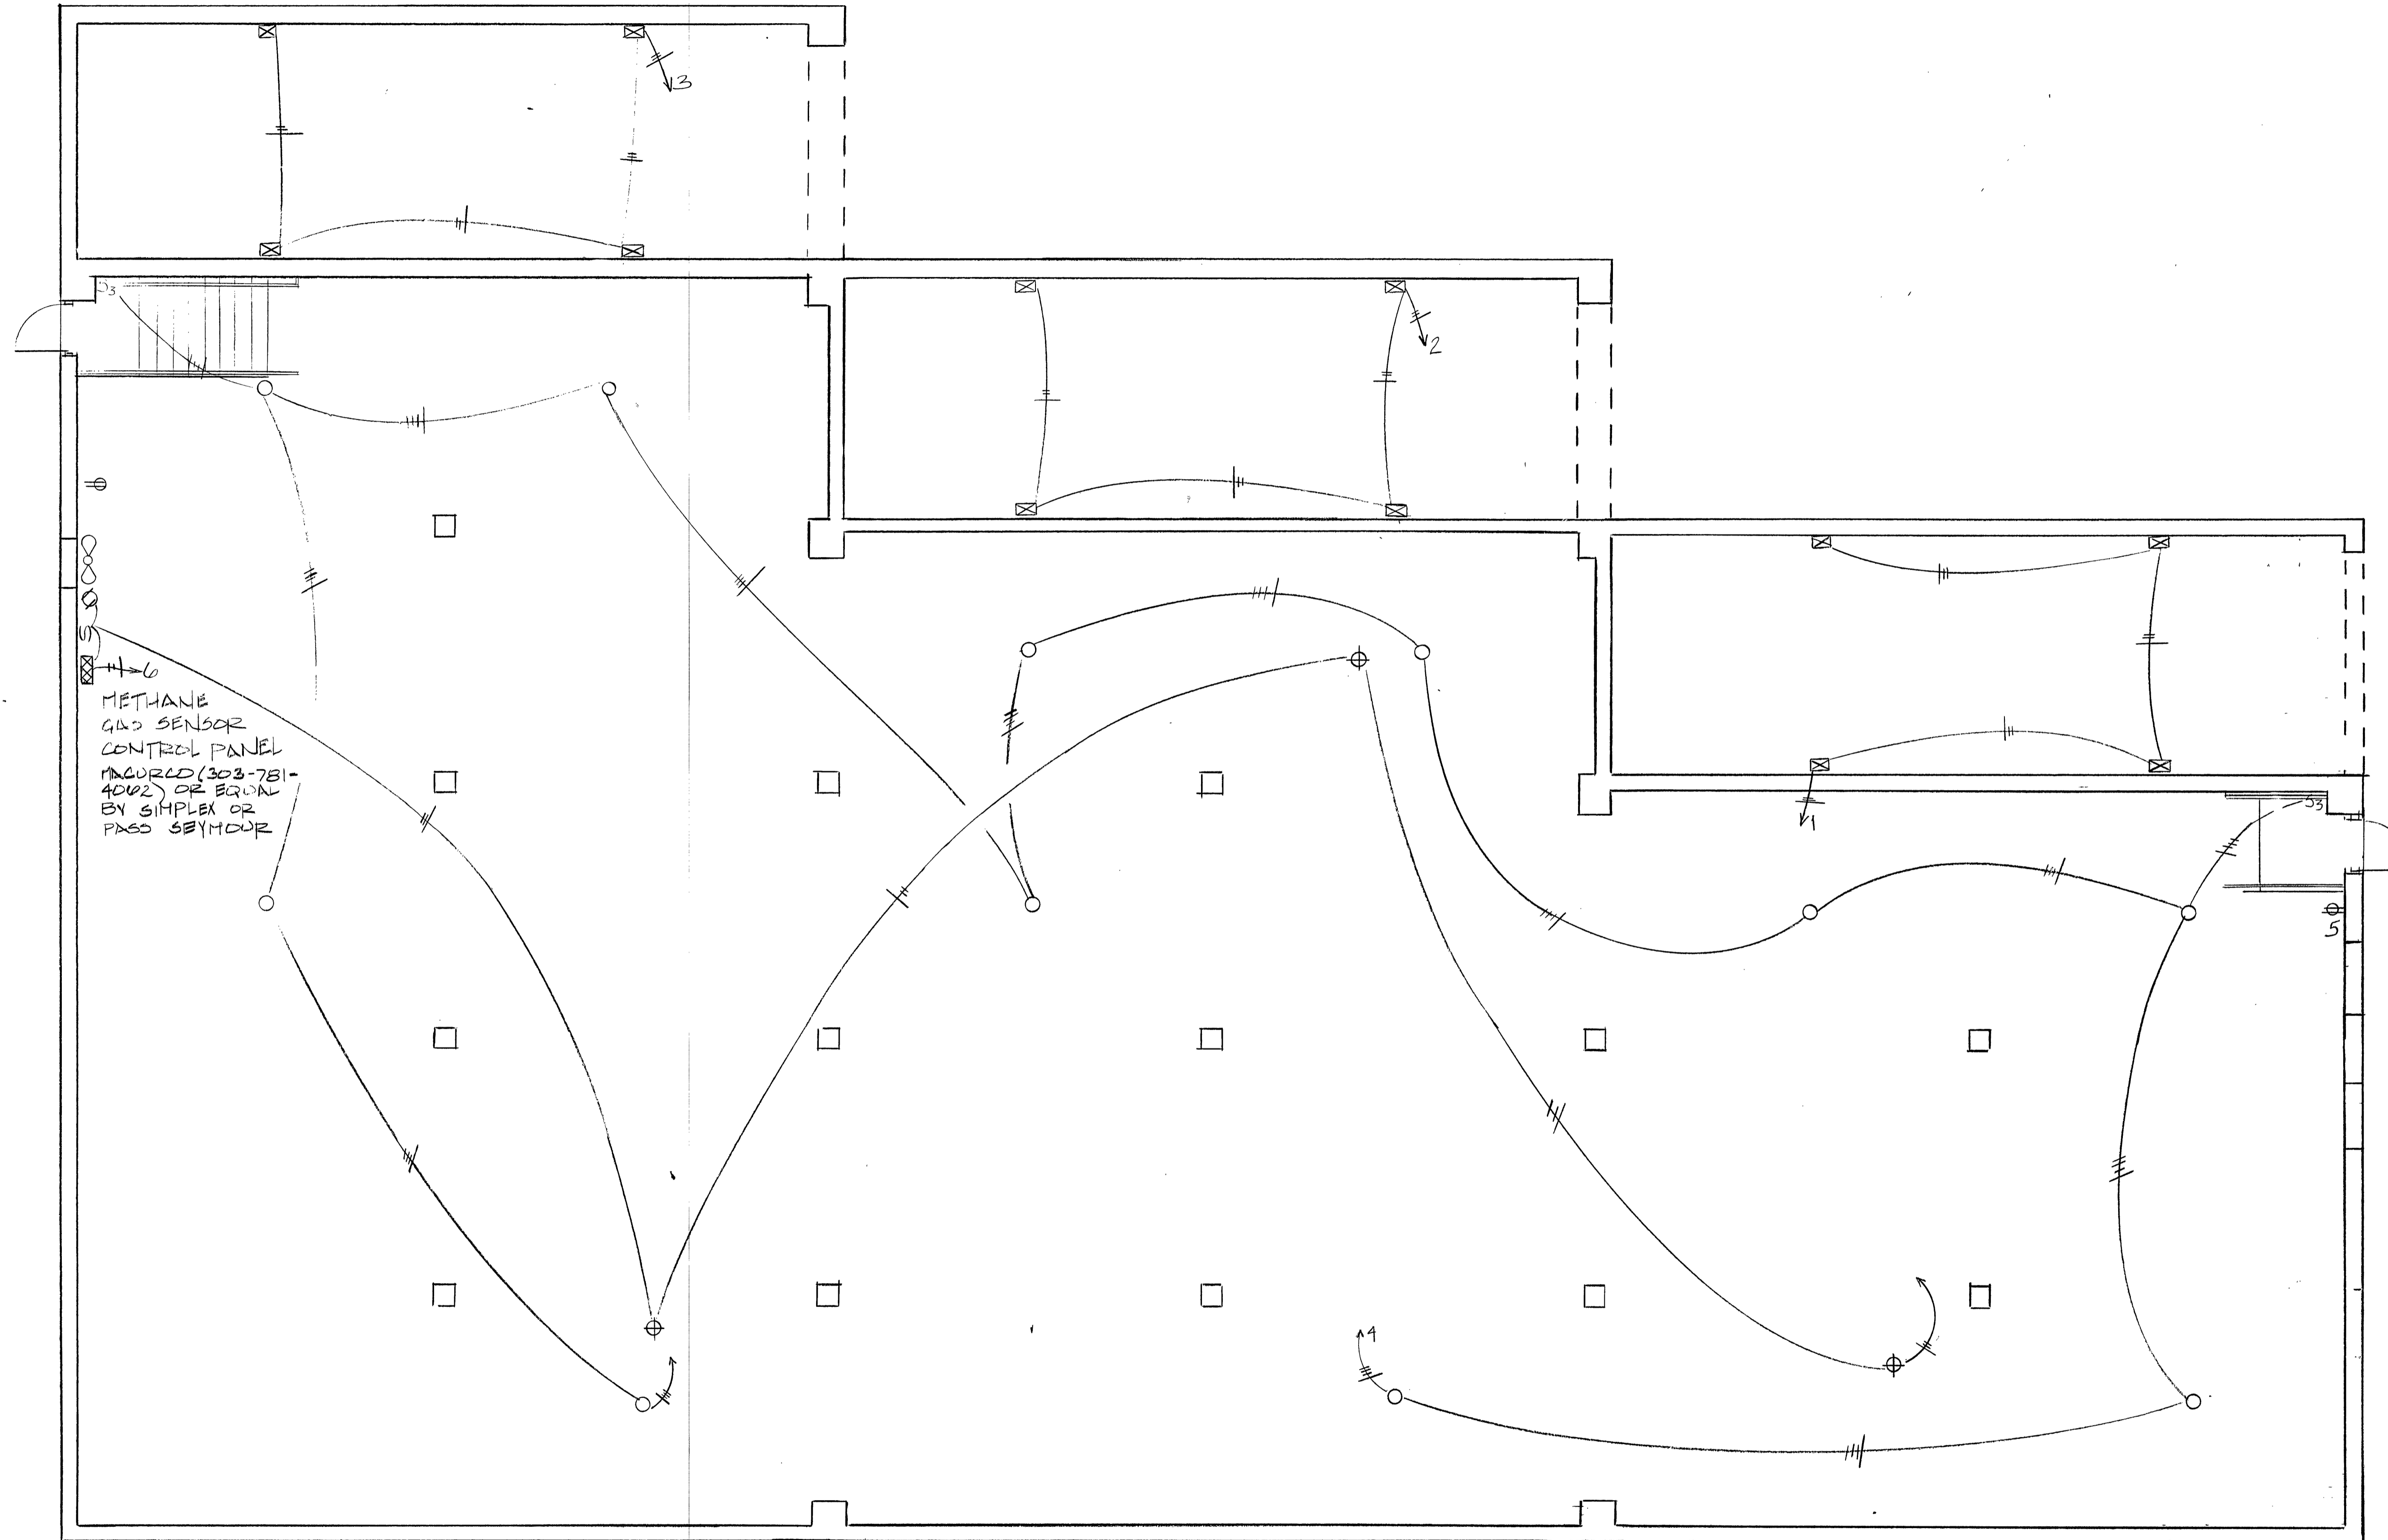

METHANE GAS SENSOR CONTROL PANEL MAJORCO (303-781-4002) OR EQUAL BY SIMPLEX OR PASS SEYMOUR

* ALL EQUIPMENT TO BE EXPLOSION PROOF IN BASEMENT *

1 LOWER LEVEL ELECTRICAL PLAN
E1 SCALE: 3/16" = 1'-0"

LEGEND

- ⊕ - METHANE GAS SENSOR - WITH MARK TIME SWITCH OVERRIDE, MAJORCO OR EQUAL BY PASS SEYMOUR
- - EXPLOSION PROOF - 100 WATT WITH METAL & GLASS COVERS. CHORD HUNG TO 9'-0". 4E. OR EQUAL BY PASS SEYMOUR
- ⊠ - WALL PACK, HIGH PRESSURE SODIUM. - PENNSYLVANIA # PK 3P-150-HPS-1204
- ⊕ - UTILITY OUTLET @ 60" AFF - WP - CE OR EQUAL
- S - SWITCH, 4E OR EQUAL