

Transfer Station


Middletown Avenue Landfill  
New Haven, Connecticut

Tipping Floor Electrical Plan

Drawn by: SKB Checked by: EKS  
Date: JULY 2, 1990  
Revisions:

E2

1115-09-B

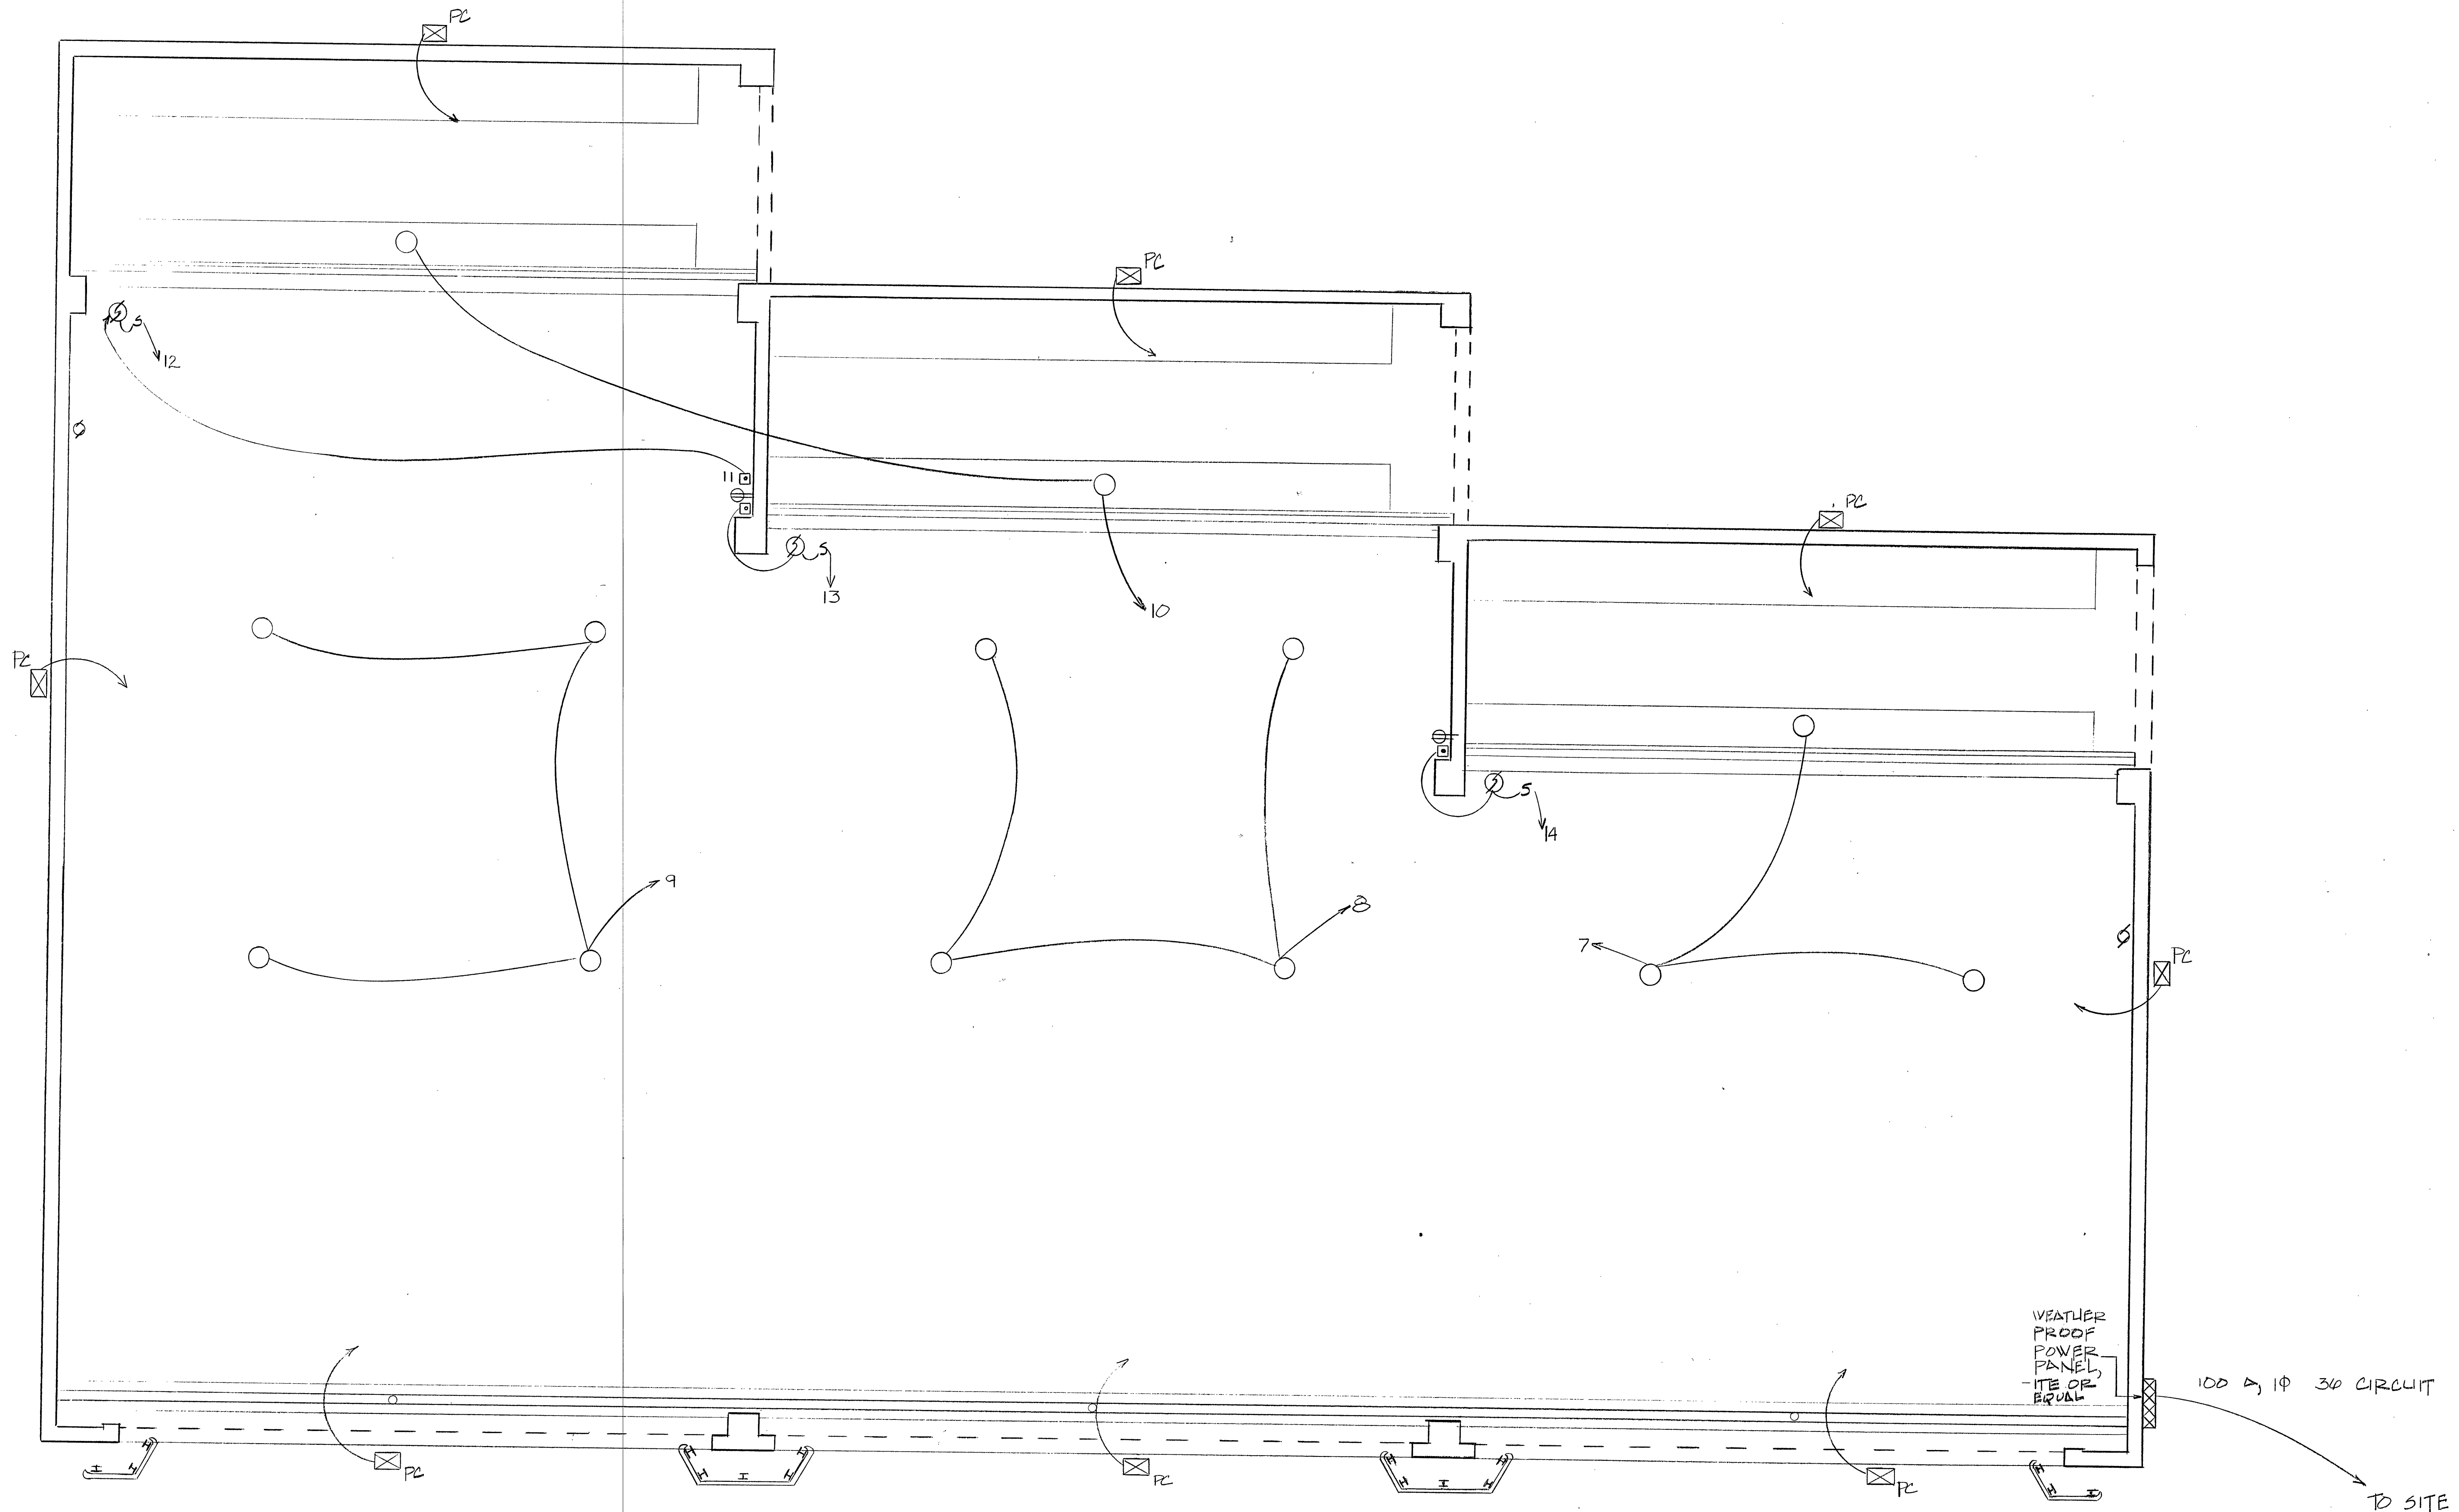

1 TIPPING FLOOR ELECTRICAL PLAN  
E2  
SCALE: 3/16" = 1'-0"

LEGEND

- ⊙ - 1HP. MOTORIZED GATE AT 16' AFF. (COORD. W/OWNER)  
COORD. W/GATE MFG. ACTUAL LOCATIONS.
- - HIGH BAY FIXTURE - HIGH PRESSURE SODIUM, SYLVANIA #MVIC-150-4PS-HL-SC-WJ
- ⊠PZ - EXT. LIGHT PHOTO ELECTRIC CONTROL SWITCH SENSOR, SYLVANIA #AK3P-250-4PS-120H
- ⊕ - UTILITY OUTLET AT 60" AFF. - WP-, 4E OR EQUAL
- ⊠S - DOOR PUSH BUTTON OPERATOR AT 60" A.F.F.
- ⊙ - SWITCH, 4E OR EQUAL